


ITEM DESCRIPTION		
SR. NO.	FOR 66 KV	SYMBOL
1	LIGHTNING ARRESTOR (1-ph) 60kV, 10KA, CL-2	
2	HDB ISOLATOR WITH 1 EARTH SWITCH 630A,25KA,3SEC.	
3	CURRENT TRANSFORMER (1-ph) 300-150/1-1-1A, 31.5KA ,3SEC	
4	CIRCUIT BREAKER 72.5 KV SF6 1600A, 25kA, 3 SEC. (3.ph)	
5	HDB ISOLATOR WITHOUT EARTH SWITCH 630/1250A,25KA,3SEC	

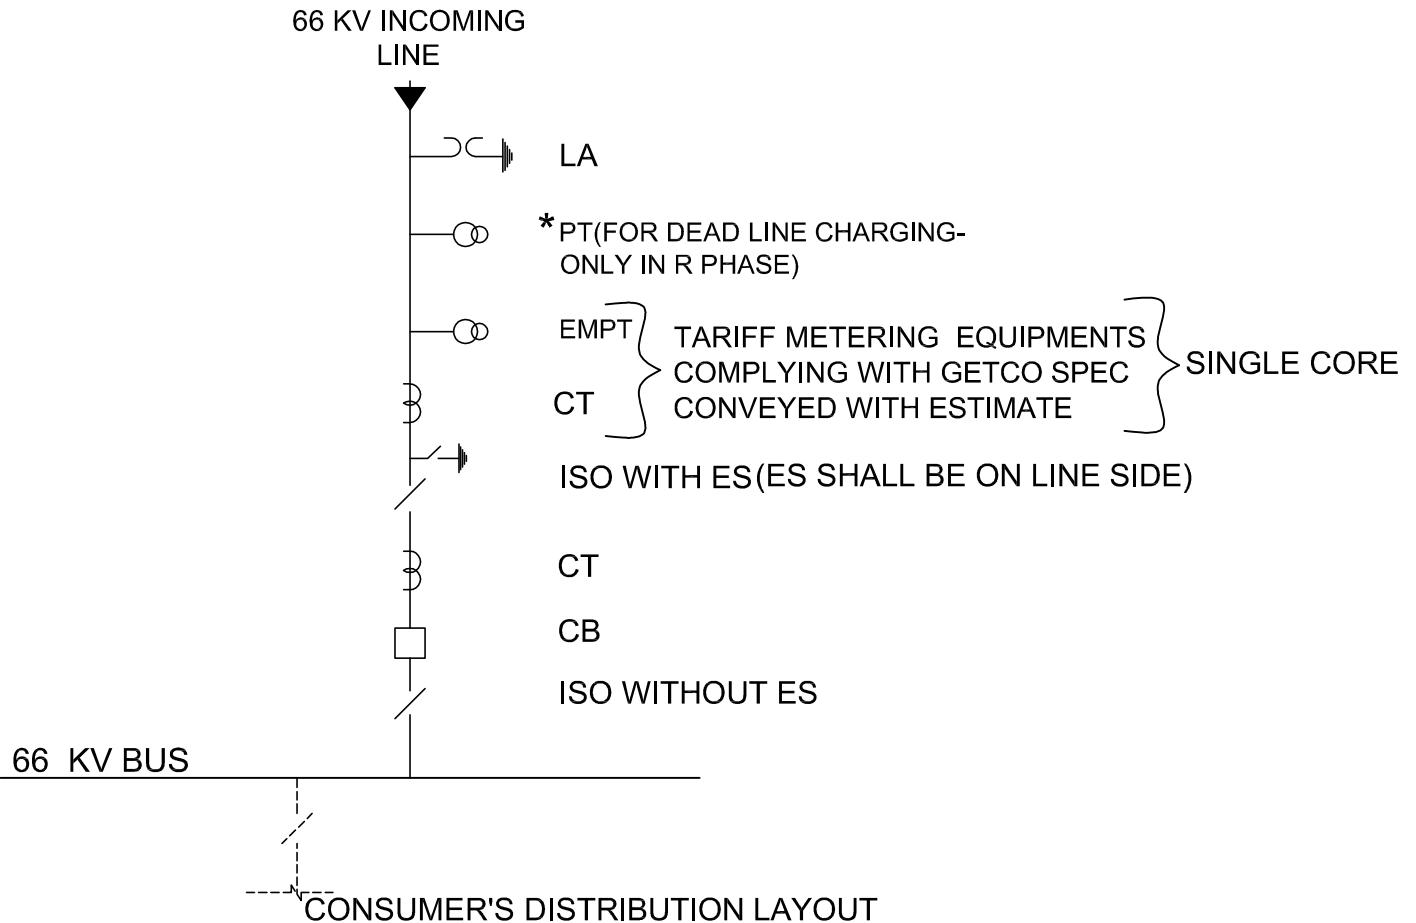

**NOTE:**

- LAYOUT PLAN & SECTIONAL VIEW SHALL BE DRAWN ACCORDINGLY.
- \*A PT FOR DEAD LINE CHARGING SHALL NOT BE APPLICABLE IN CASE OF THOSE CONSUMERS WHO DO NOT HAVE THEIR OWN GENERATION.
- ALL THE EQUIPMENTS RELATED TO THE ESTIMATE SERVED SHALL BE PROCURED AS PER GETCO SPECIFICATIONS.THE INDIVIDUAL APPROVAL FOR EACH EQUIPMENT SHALL HAVE TO BE OBTAINED FROM GETCO, IF CONSUMER IS DEVIATING FROM STANDARD SPECIFICATIONS.

		<b>GUJARAT ENERGY TRANSMISSION CORPN.LTD.</b> S.P.VIDYUT BHAVAN, RACE COURSE, VADODARA - 390 007	
		STANDARD SINGLE LINE DIAGRAM OF 66 KV SUB-STATION AT CONSUMER END OF EHT DEPOSIT SCHEME	
DRAWN:	CHECKED:	APPD:	
D.K.P.	P.B.M.	EE(ENGG.) CE(ENGG.)	SIZE: A4
SCALE:	DATE:	DRG. NO:	SHEET: REV:
N.T.S.	19.01.2010	GETCO / E / 06S-STD / P-002A	1 OF 1 R0

R0	FIRST PREPERATION DT.05.01.2010
REV:	DESCRIPTION: